


These Plans are the property of THE PLAN FACTORY and are to be used only for the project or raised without the written permission of THE PLAN FACTORY. THE PLAN FACTORY shall not be responsible for the builder's interpretation of the plans. The owner to verify all local Building Codes & Restrictions. Building Codes & Restrictions may vary prior to any construction.



FRONT ELEVATION
1/4"=1'-0"

THE PLAN FACTORY

4303 SOUTH BOWEN RD. - SUITE 117 - ARLINGTON, TX 76016
METRO (817) 654-9012

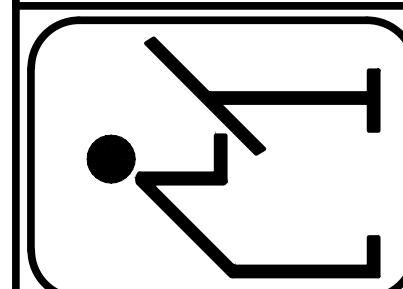

DESCRIPTION

SQUARE FOOTAGE:	
LOWER:	5262
UPPER:	0
TOTAL A/C:	5262
GARAGE: 832	
PORCH: 342	
PATIO: 618	
TTL AUR: 7054	


Drawn SC/RKJ
Job 5105
Date MAY 2015

PLAN NO.

5505155262

CRAFTSMAN COTTAGE ELEVATION WITH DEEP OVERHANGS AND DECORATIVE GABLE BRACKETS
WOOD OR COMPOSITION TAPERED BOX COLUMNS ON MASONRY BASE - PRODUCT TBD
LOW MAINTENANCE MASONRY COMPOSITE SHAKE, SIDING AND TRIM PRODUCTS
METAL ROOFING TO BE SELECTED BY OWNER

NOTE: IT IS THE SOLE RESPONSIBILITY OF THE BUILDER TO VERIFY ALL ASPECTS OF THIS PLAN AND TO ENSURE THAT THIS PLAN MEETS ALL GOVERNING CODES & REQUIREMENTS

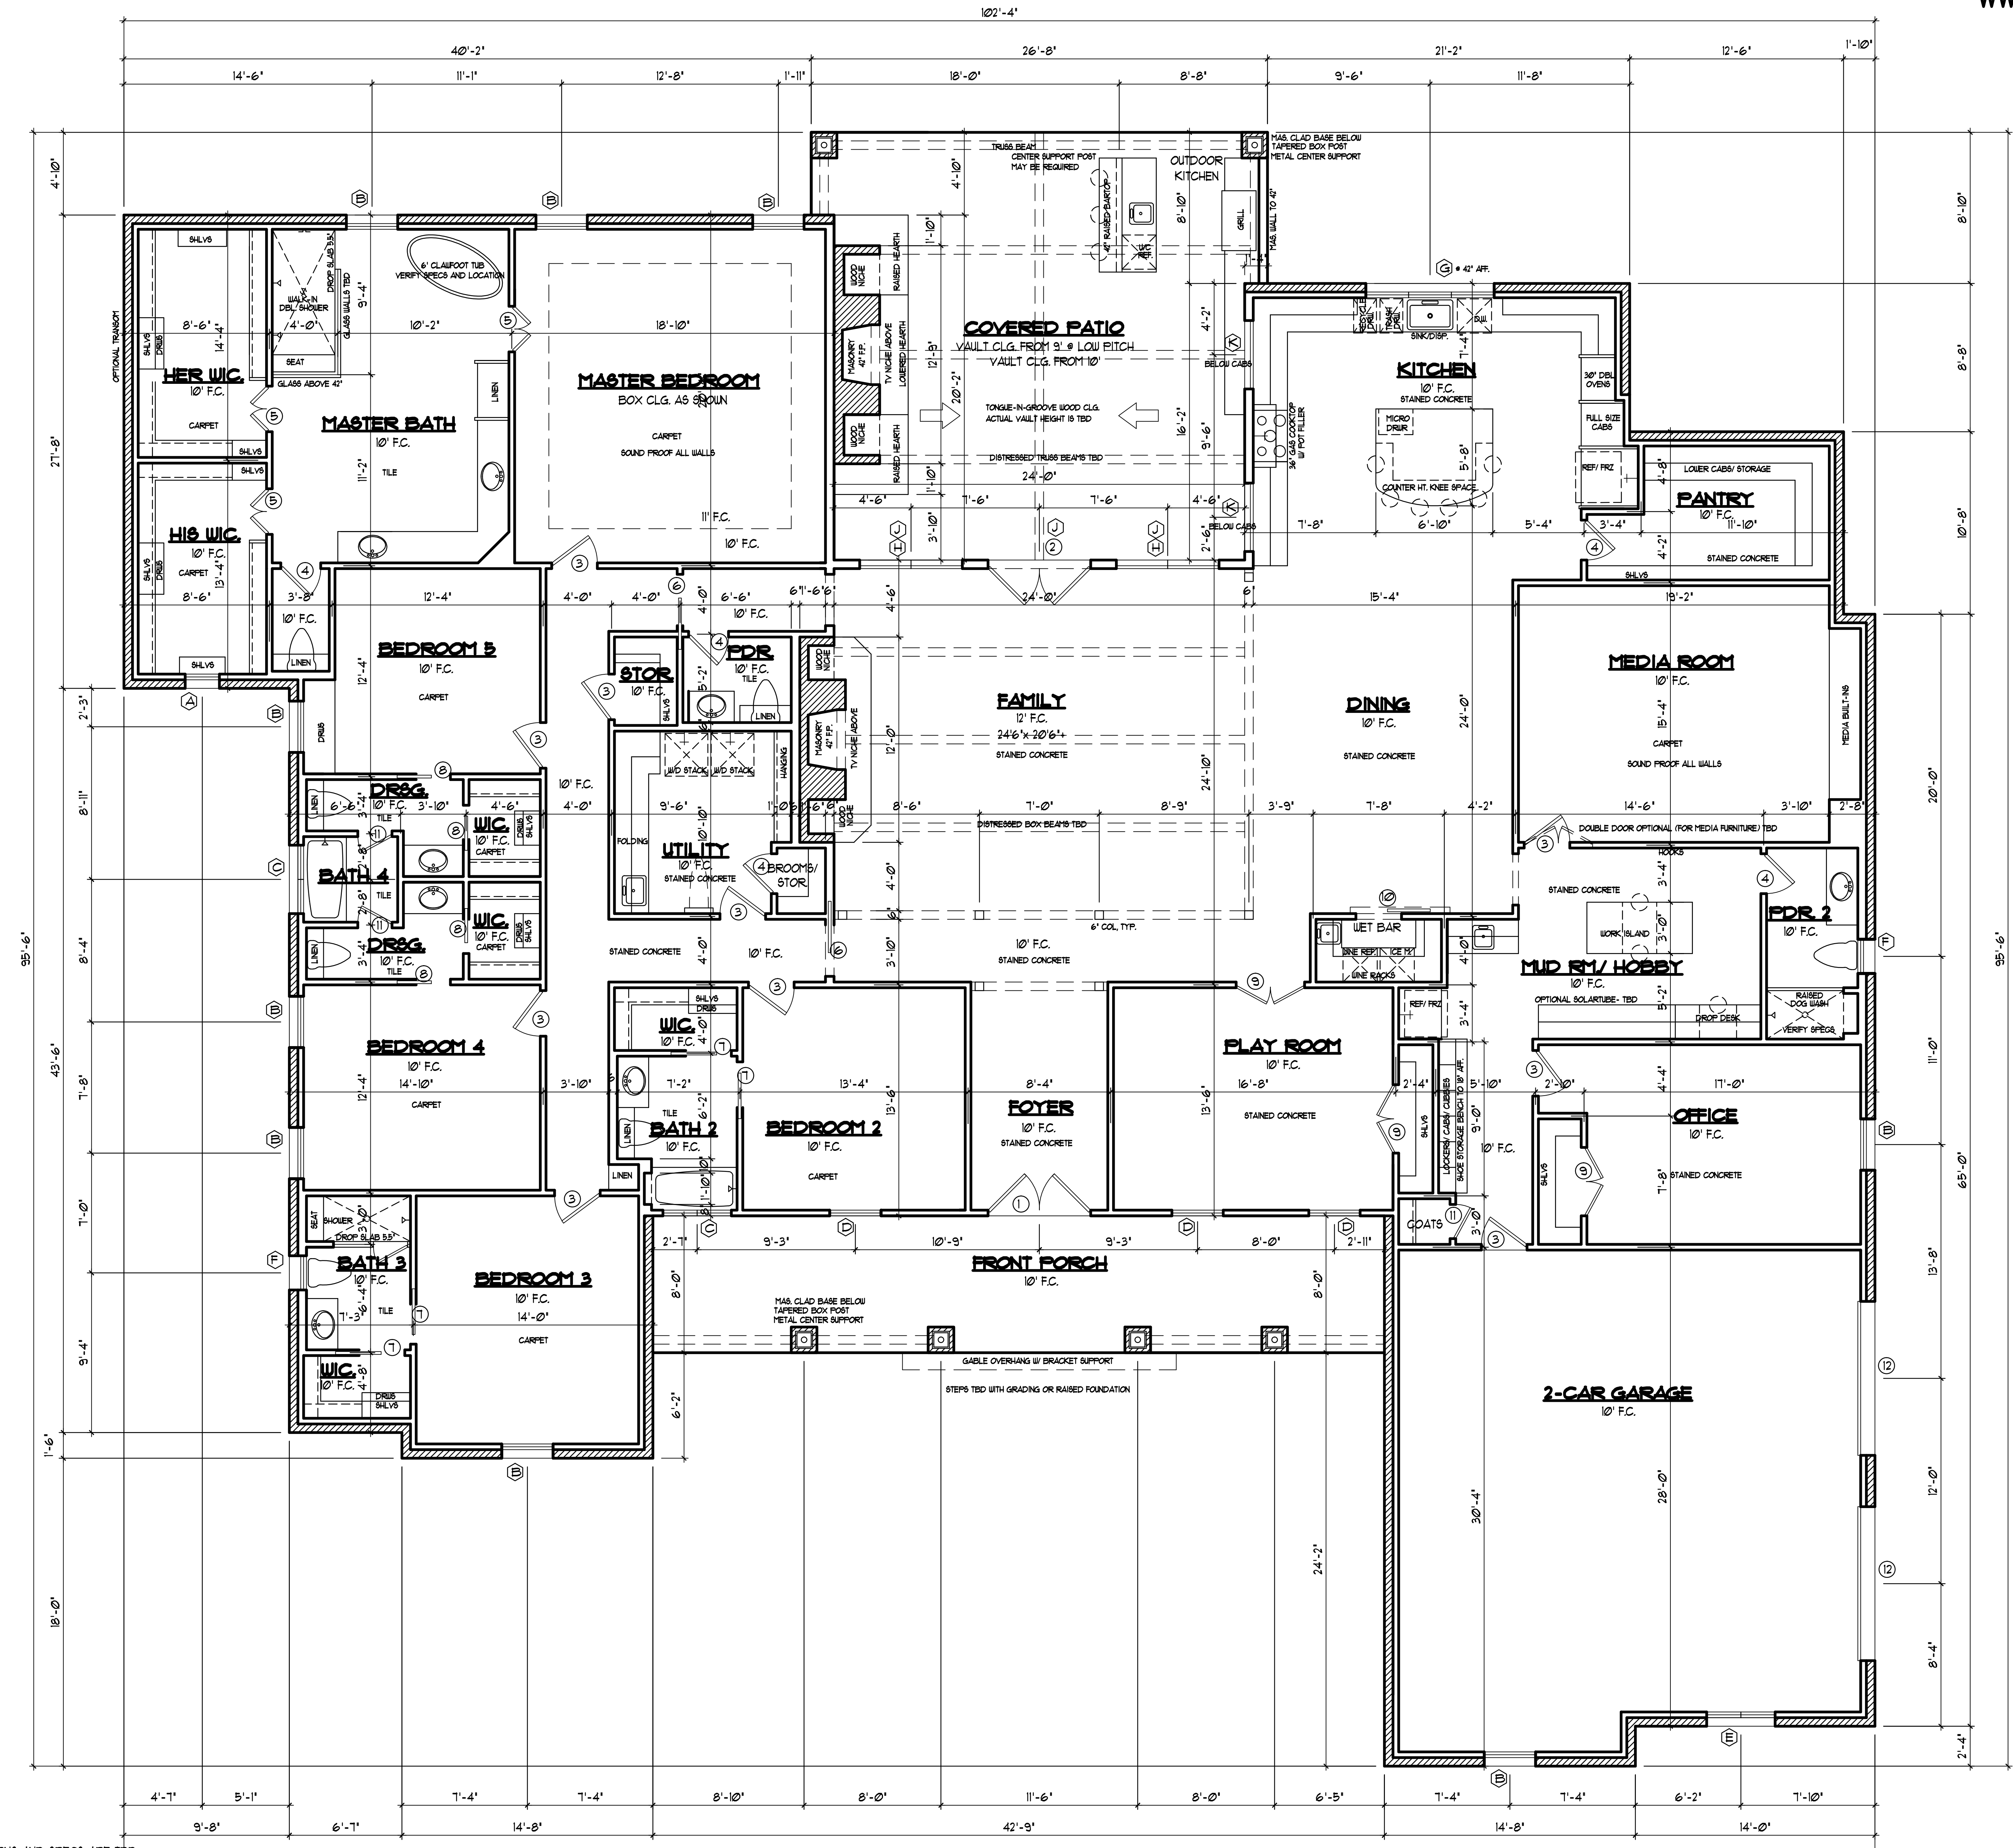


WINDOWS			
A	2026	FIXED	
B	3050	SH	
C	(2) 2020	SH	MULLED
D	3060	SH	
E	(2) 2040	SH	
F	2040	SH	
G	(3) 2646	1-FX, 2-COMNT	
H	(2) 3070	SH	
J	6020	FIXED	MULLED
K	4014	HORIZ	
L	(3) 2020	FIXED	MULLED

DOORS			
1	(2) 3080	SC	
2	(2) 3080	SC	FRENCH
3	2880	SC	
4	2480	SC	
5	(2) 1480	SC	
6	3080	SC	POCKET
7	2880	SC	POCKET
8	2080	SC	POCKET
9	(2) 2080	SC	
10	2680	SC	BARN
11	2080	SC	
12	9080	EXT.	GARAGE

These Plans are the property of THE PLAN FACTORY and are not to be reproduced, copied, or used without the written permission of THE PLAN FACTORY. THE PLAN FACTORY shall not be held responsible for any errors or omissions on the part of the builder. The builder shall be responsible for verifying all local Building Codes & Restrictions, Building Codes & Ordinances prior to any construction.

THE PLAN FACTORY
 4303 SOUTH BOWEN RD. - SUITE 117 - ARLINGTON, TX 76016
 METRO (817) 654-9012

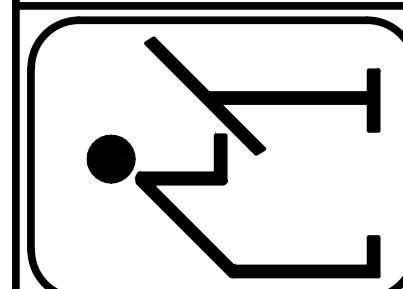

DESCRIPTION	
SQUARE FOOTAGE:	
LOWER:	5262
UPPER:	0
TOTAL A/C:	5262
GARAGE:	832
PORCH:	342
PATIO:	618
TTL AUR:	7054

Drawn: SC/RKJ
 Job: 5185
 Date: MAY 2015

PLAN NO.


5505155262

PG. 2 OF 6

GENERAL NOTES:
 ALL MECHANICAL SYSTEM LOCATIONS AND SPECS ARE TBD
 ALL ENGINEERING TO BE PROVIDED BY OTHERS
 2x6 FRAMING IN SOME PLUMBING, KEY STRUCTURAL AND ALL WALLS FRAMED TO 12" OR MORE
 SEE OWNERS FOR ALL MILLWORK, CASEWORK AND FINISHES

FLOOR PLAN
 1/4"=1'-0"

NOTE: IT IS THE SOLE RESPONSIBILITY OF THE BUILDER TO VERIFY ALL ASPECTS OF THIS PLAN AND TO ENSURE THAT THIS PLAN MEETS ALL GOVERNING CODES & REQUIREMENTS

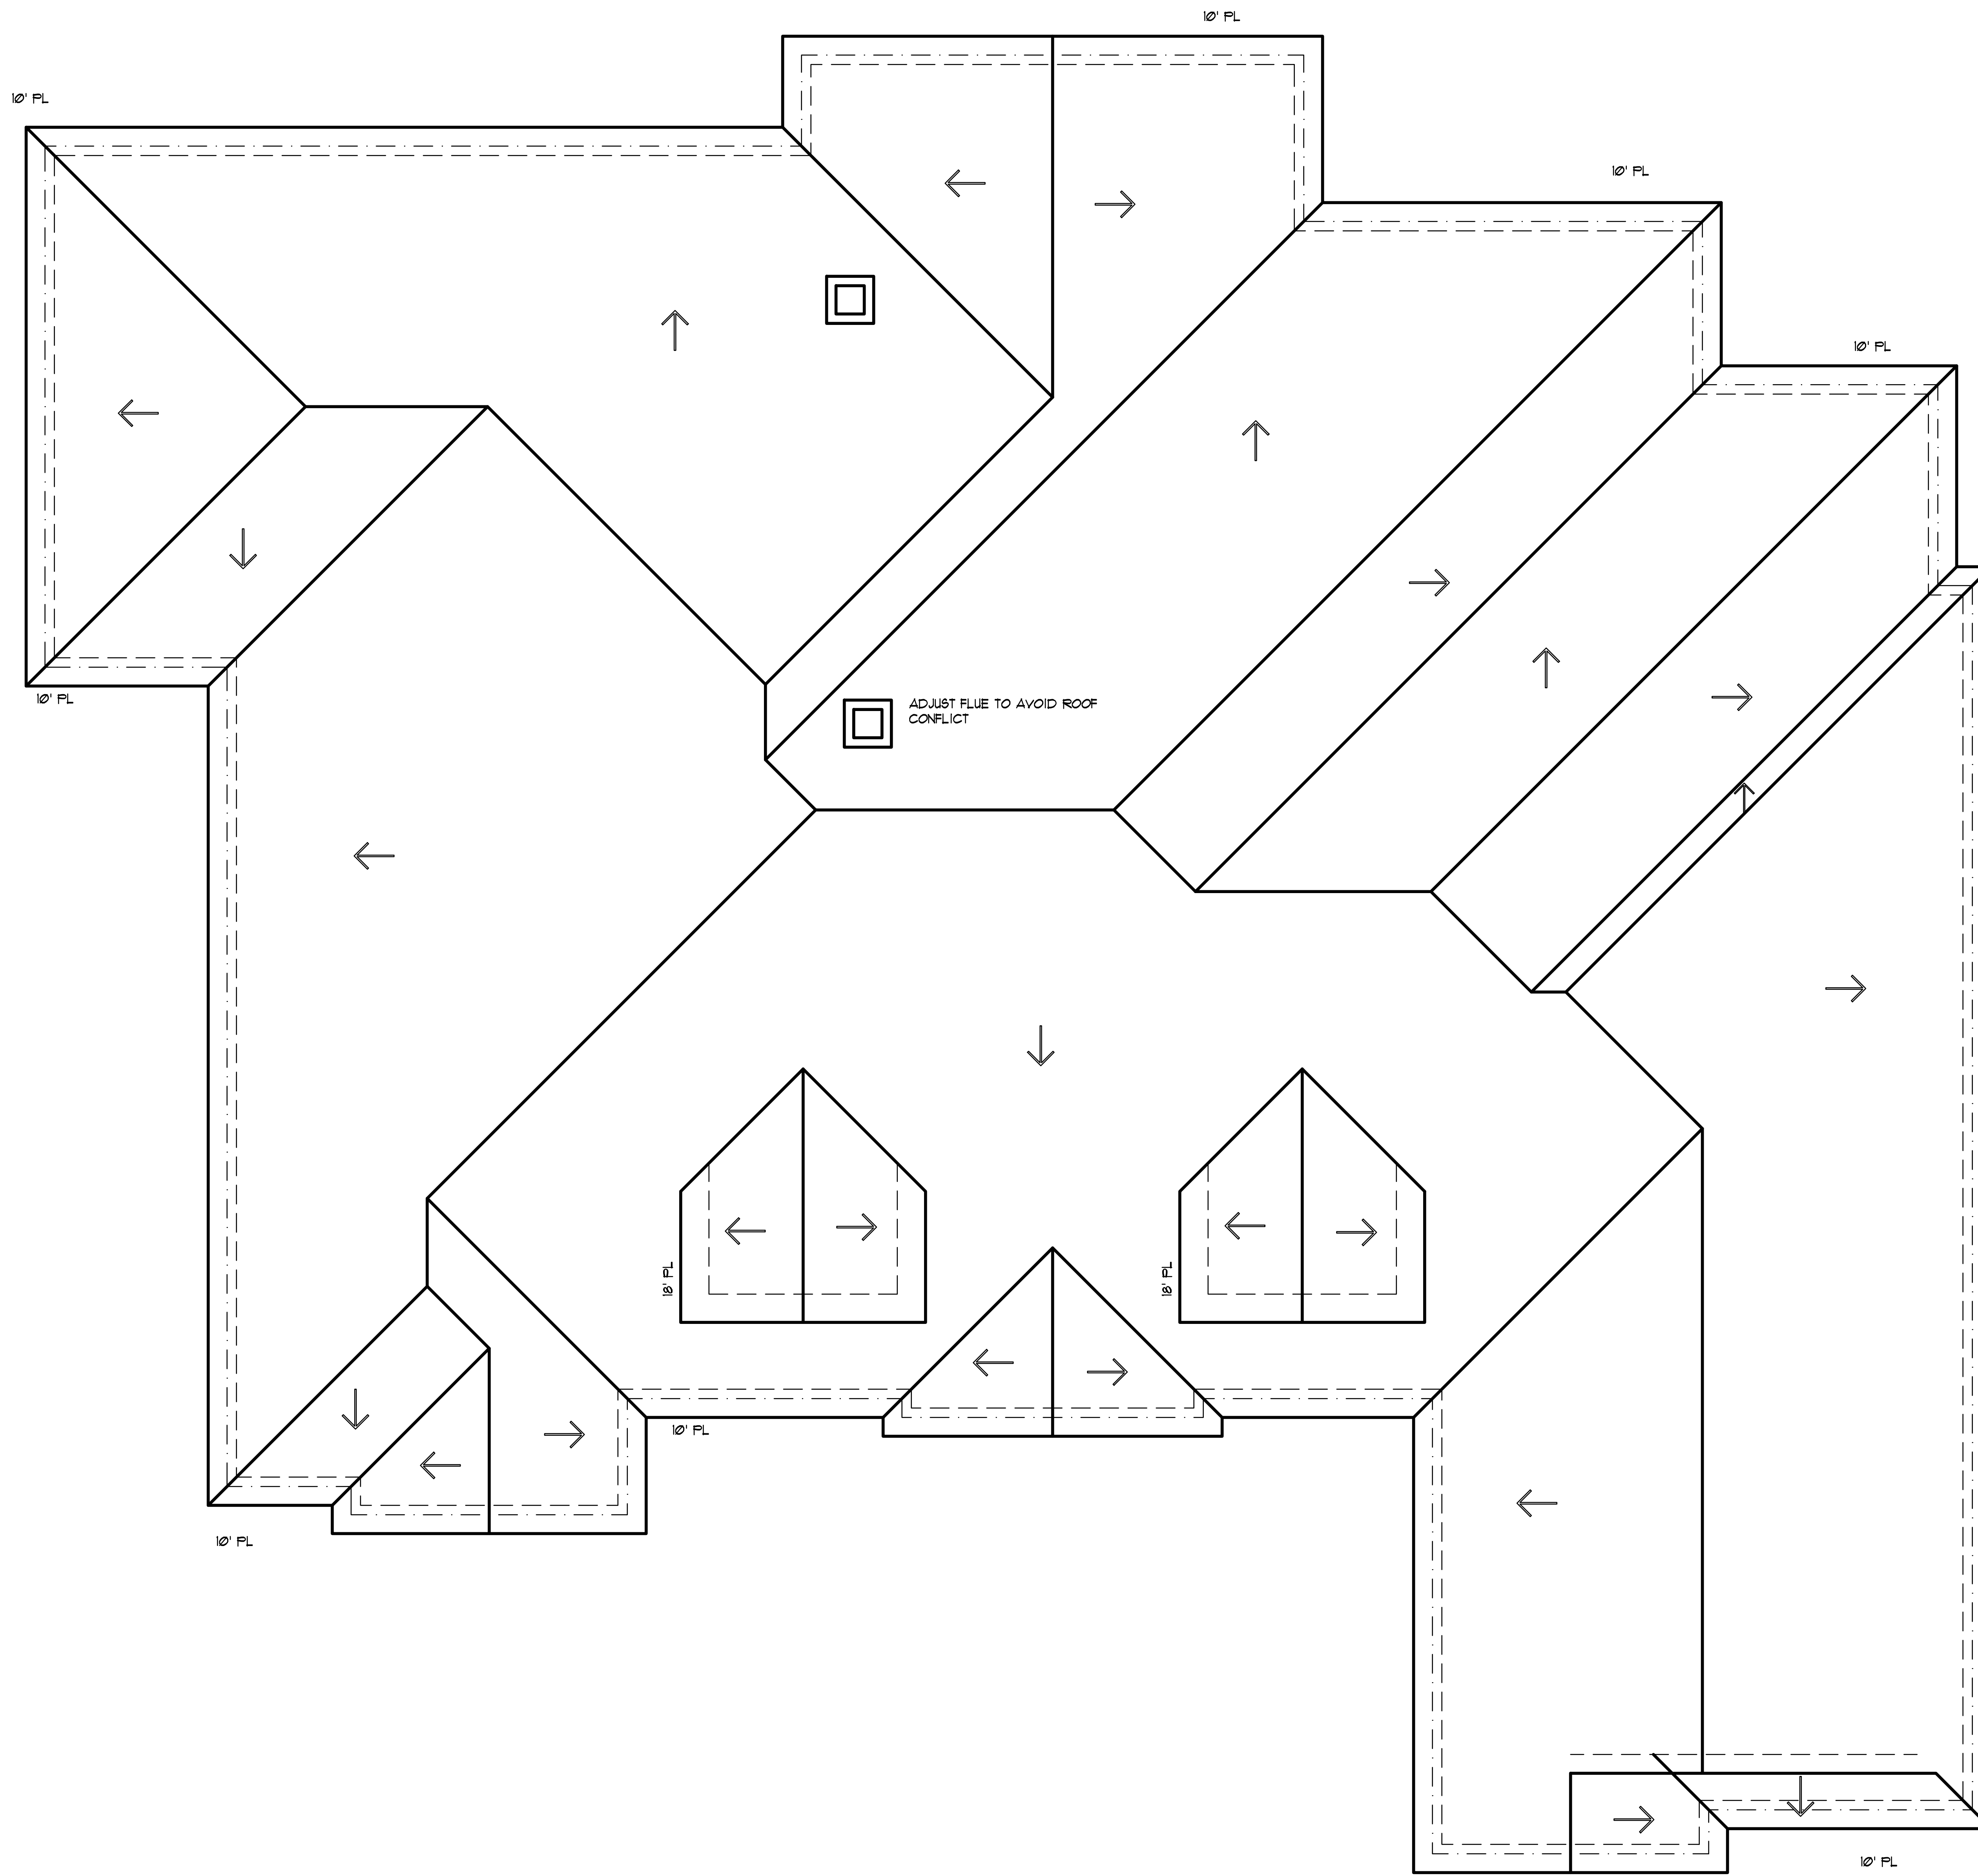


ROOF PLAN - 8:12 PITCH

1/4"=1'-0"
 - - - 1'-0" OVERHANG FROM ROCK
 - - - 1'-6" OVERHANG FROM FACE OF SIDING

NOTE: IT IS THE SOLE RESPONSIBILITY OF THE BUILDER TO VERIFY ALL ASPECTS OF THIS PLAN AND TO ENSURE THAT THIS PLAN MEETS ALL GOVERNING CODES & REQUIREMENTS

These Plans are the property of THE PLAN FACTORY and are to be used only for the project or raised without the written permission of THE PLAN FACTORY. THE PLAN FACTORY shall not be held responsible for any errors, omissions, or omissions. The builder or owner to verify all local Building Codes & Restrictions. Building Codes & Restrictions apply prior to any construction.

THE PLAN FACTORY
 4303 SOUTH BOWEN RD. - SUITE 117 - ARLINGTON, TX 76016
 METRO (817) 654-9012

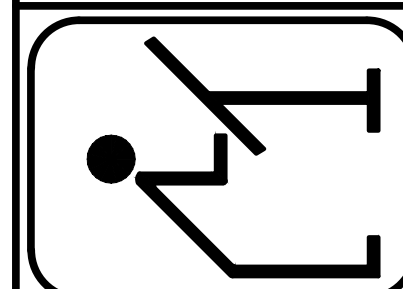

DESCRIPTION


Drawn SC/RKJ
 Job 5105
 Date MAY 2015

PLAN NO.




 
 


 
 
 
 


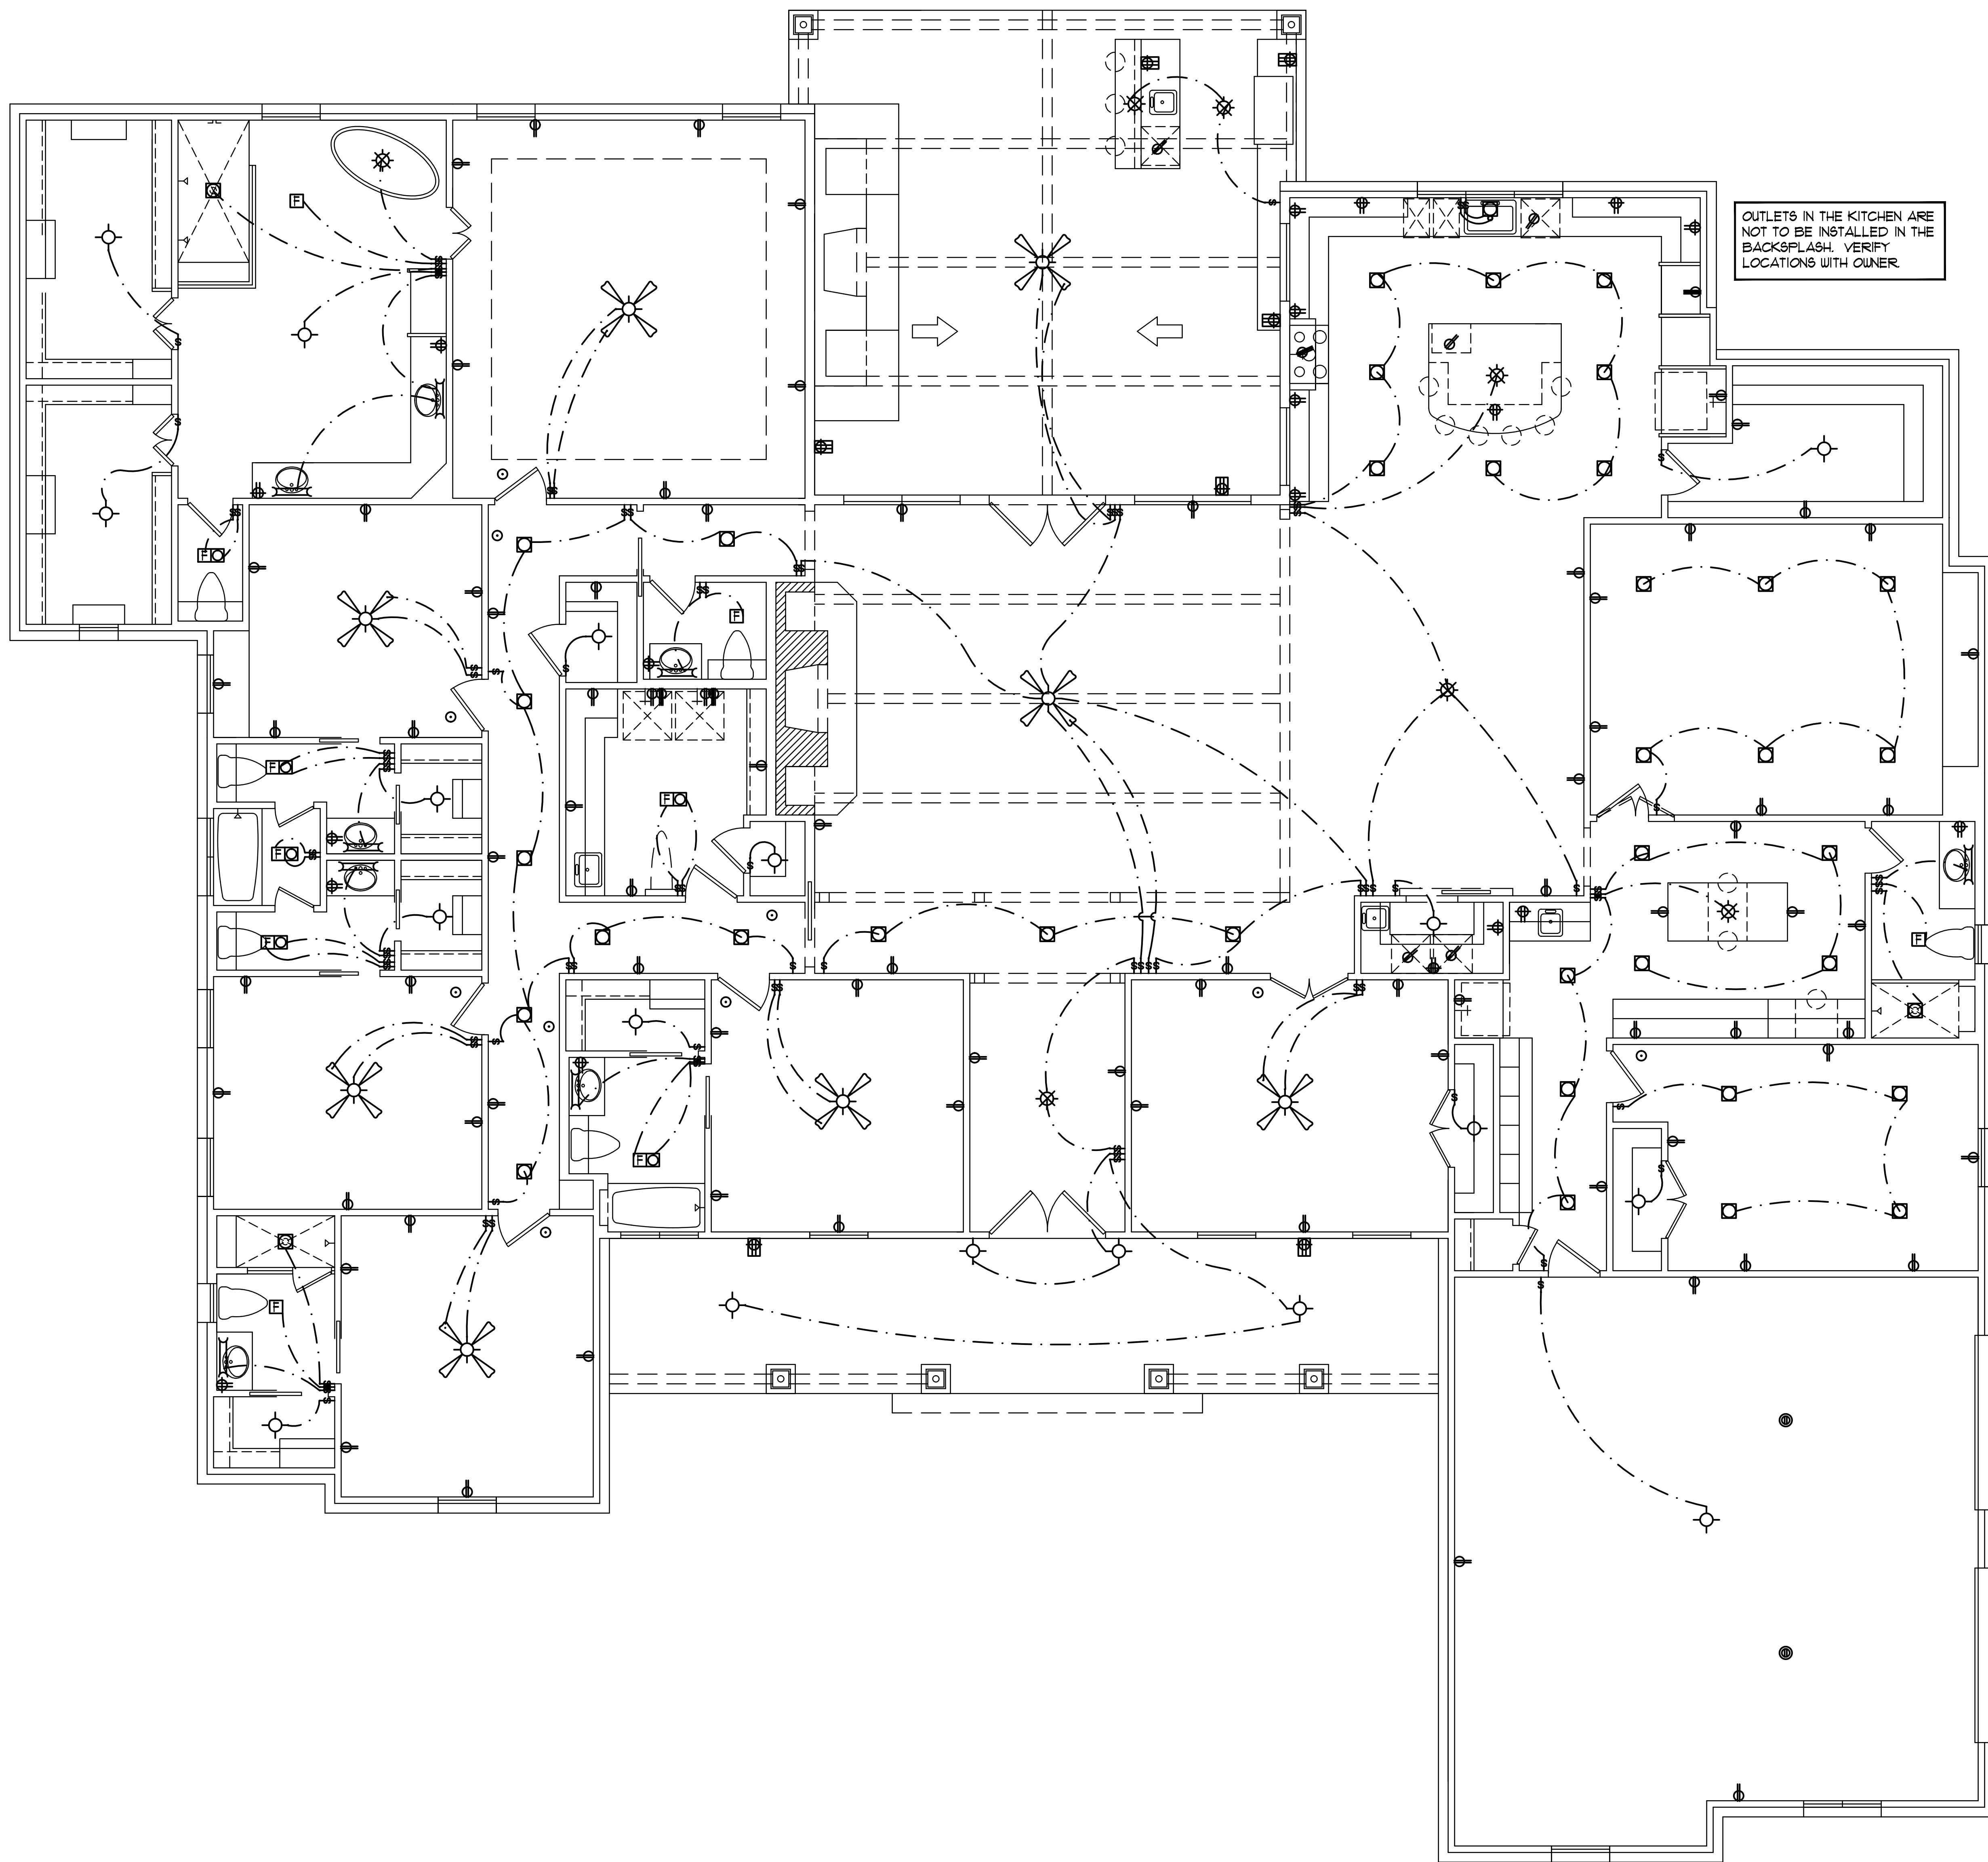



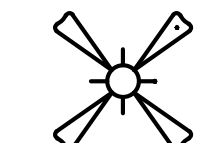











5505155262

PG. 3 OF 6

  These Plans are the property of THE PLAN FACTORY and are not to be reproduced, copied, or raised without the written permission of THE PLAN FACTORY. THE PLAN FACTORY shall have no responsibility or liability to the owner to verify all Deed Restrictions, Building Codes & local ordinances prior to any construction.



ELECTRICAL LEGEND

-  CEILING FAN WITH LIGHT KIT
VERIFY WITH OWNER
-  EXHAUST FAN AND LIGHT COMBINATION
-  EXHAUST FAN
-  1'x4' FLUORESCENT FIXTURE SURFACE MOUNT
VERIFY WITH OWNER
-  2'x4' FLUORESCENT FIXTURE SURFACE MOUNT
VERIFY WITH OWNER
-  RECESSED LIGHT FIXTURE
-  RECESSED WALL-WASH FIXTURE
INCANDESCENT FIXTURE
VERIFY WITH OWNER
-  SCONCE LIGHT
-  HANGING LIGHT
-  LIGHT FIXTURE
-  LIGHT STRIP
-  TRACK LIGHTING
-  UNDER UPPER CABINET STRIP LIGHTING
-  UPLIGHT
-  DOUBLE-HEAD FLOOD FIXTURE
-  110 V WATERPROOF 20 AMP G.F.I. OUTLET
-  110 V GROUND FAULT INTERRUPTER OUTLET
-  220 V. OUTLET
VERIFY HEIGHTS
-  110 V FLOOR OUTLET
SEE OWNER /LOC.
-  EYE PLUG
-  110 V AT CEILING
-  110 V. OUTLET
VERIFY HEIGHTS
-  SWITCH
-  THERMOSTAT
-  SMOKE DETECTOR
AC/DC
-  CARBON MONOXIDE DETECTOR
AC/DC
-  CHIMES
-  TELEVISION
-  TELEPHONE


OUTLETS IN THE KITCHEN ARE NOT TO BE INSTALLED IN THE BACKSPLASH. VERIFY LOCATIONS WITH OWNER.

NOTE: ELECTRICAL LAYOUT IS PROVIDED ONLY AS A GUIDELINE FOR BASIC FEATURES. IT IS THE SOLE RESPONSIBILITY OF THE BUILDER TO COMPLY WITH ALL GOVERNING AUTHORITIES.

ELECTRICAL PLAN
1/4"=1'-0"

NOTE: IT IS THE SOLE RESPONSIBILITY OF THE BUILDER TO VERIFY ALL ASPECTS OF THIS PLAN AND TO ENSURE THAT THIS PLAN MEETS ALL GOVERNING CODES & REQUIREMENTS

THE PLAN FACTORY
 4303 SOUTH BOWEN RD. - SUITE 117 - ARLINGTON, TX 76016
 METRO (817) 654-9012

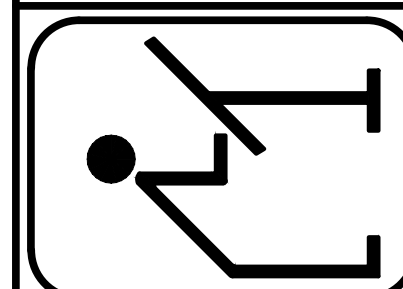

DESCRIPTION


Drawn SC/RKJ
 Job 5105
 Date MAY 2015

PLAN NO.


5505155262

PG. 4 OF 6

These Plans are the property of THE PLAN FACTORY and are to be used only for the project or raised without the written permission of THE PLAN FACTORY. THE PLAN FACTORY shall not be held responsible for the builder's failure to verify all Deed Restrictions, Building Codes & other applicable codes prior to any construction.

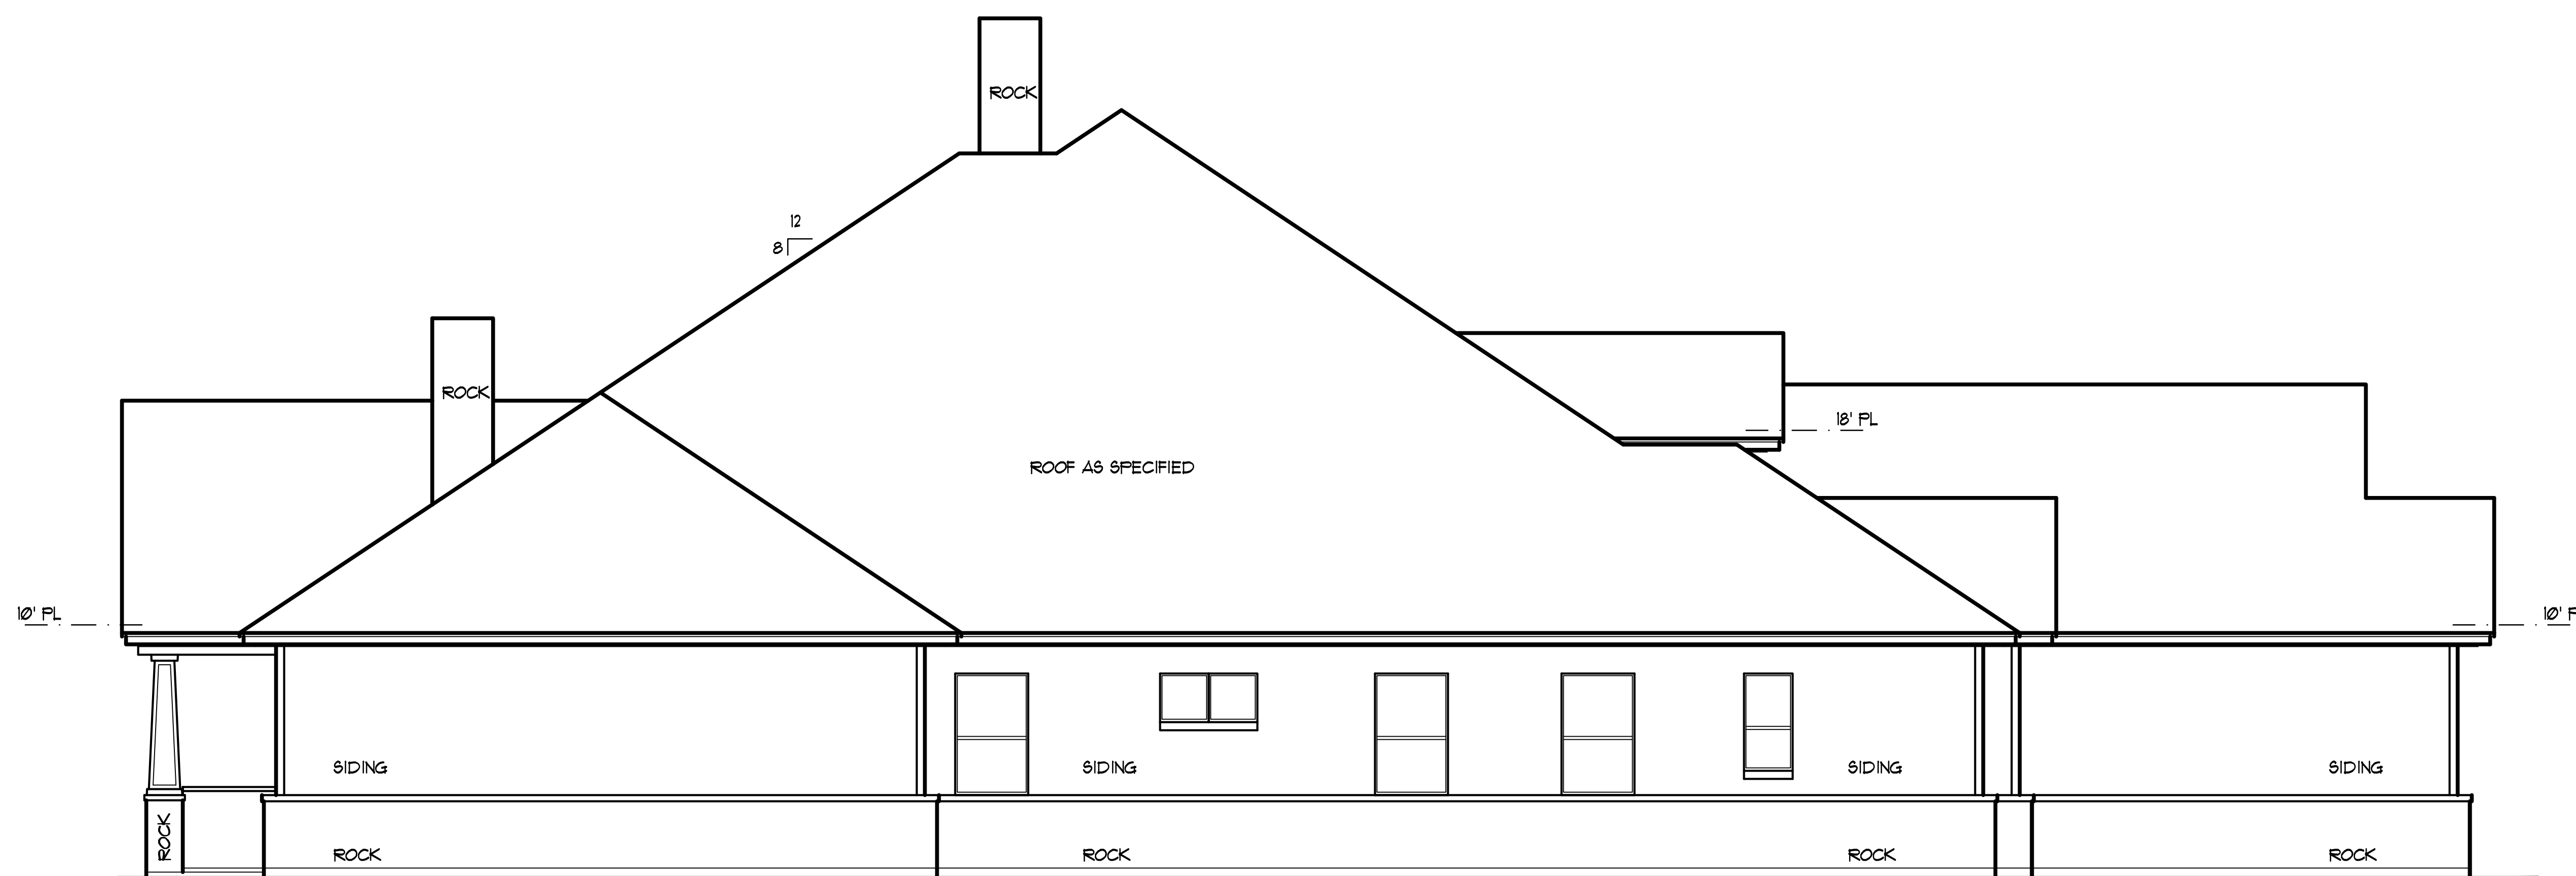


LEFT ELEVATION
1/4"=1'-0"

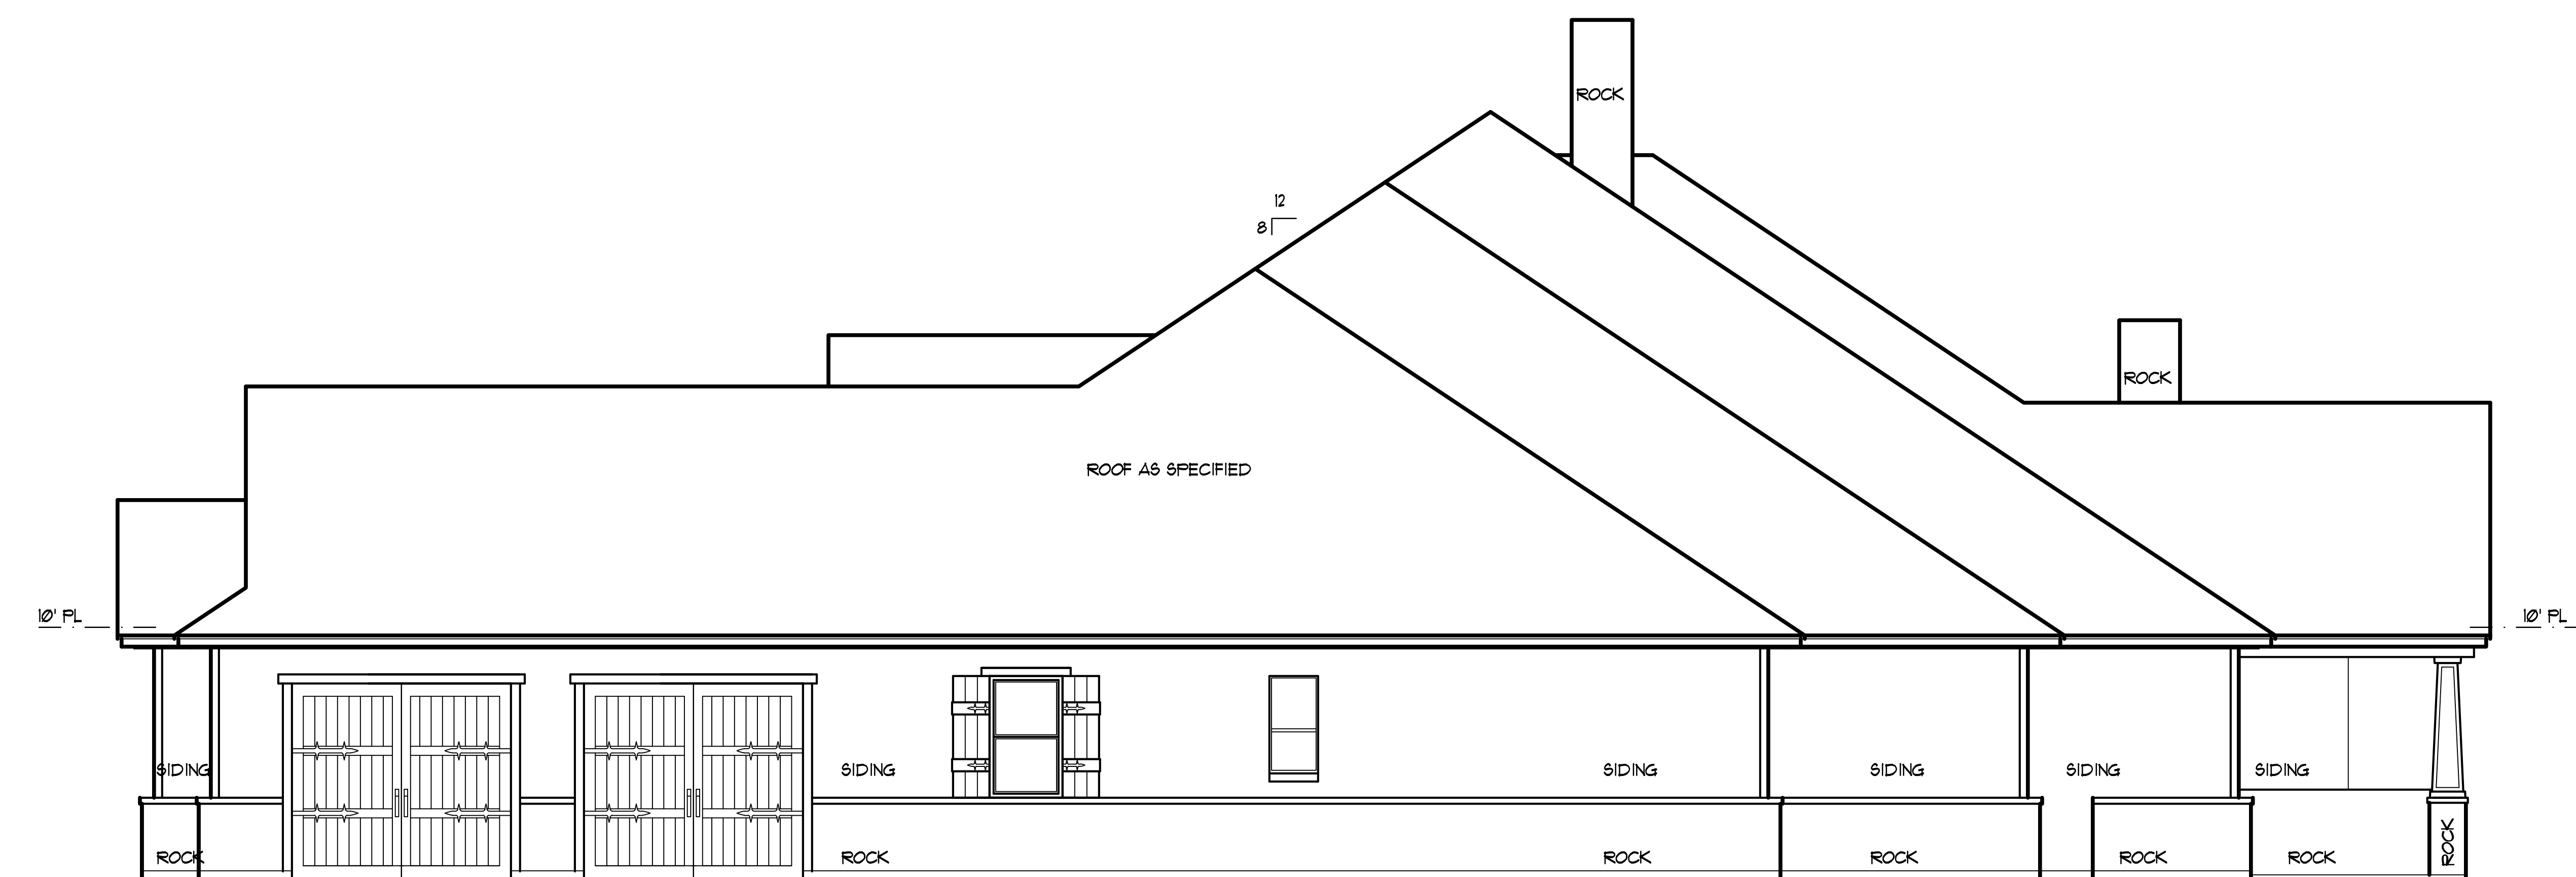

RIGHT ELEVATION
1/4"=1'-0"

THE PLAN FACTORY
4303 SOUTH BOWEN RD. - SUITE 117 - ARLINGTON, TX 76016
METRO (817) 654-9012

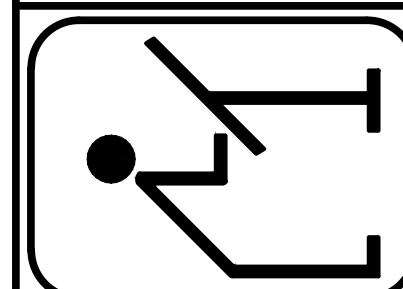

DESCRIPTION

Drawn SC/RKJ
Job 5105
Date MAY 2015

PLAN NO.

5505155262

PG. 5 OF 6

NOTE: IT IS THE SOLE RESPONSIBILITY OF THE BUILDER TO VERIFY ALL ASPECTS OF THIS PLAN AND TO ENSURE THAT THIS PLAN MEETS ALL GOVERNING CODES & REQUIREMENTS

